



116 Roosevelt Avenue, Suite 200 / P.O. Box 405 / Albany, Georgia 31702 / (229)355-0036


Drawn	CTS	No.	Date	Revision
Checked	BJM			
Design	WCL			
Architect	0703			

NEW BMW DEALERSHIP
ALBANY MOTOR CARS
E. OGLETHORPE BLVD.
ALBANY, GEORGIA

Yielding
Wakeford & McGee Architects, P.C.

Sheet No. **E6**
 Drawing

NOTES: (THIS SHEET ONLY)

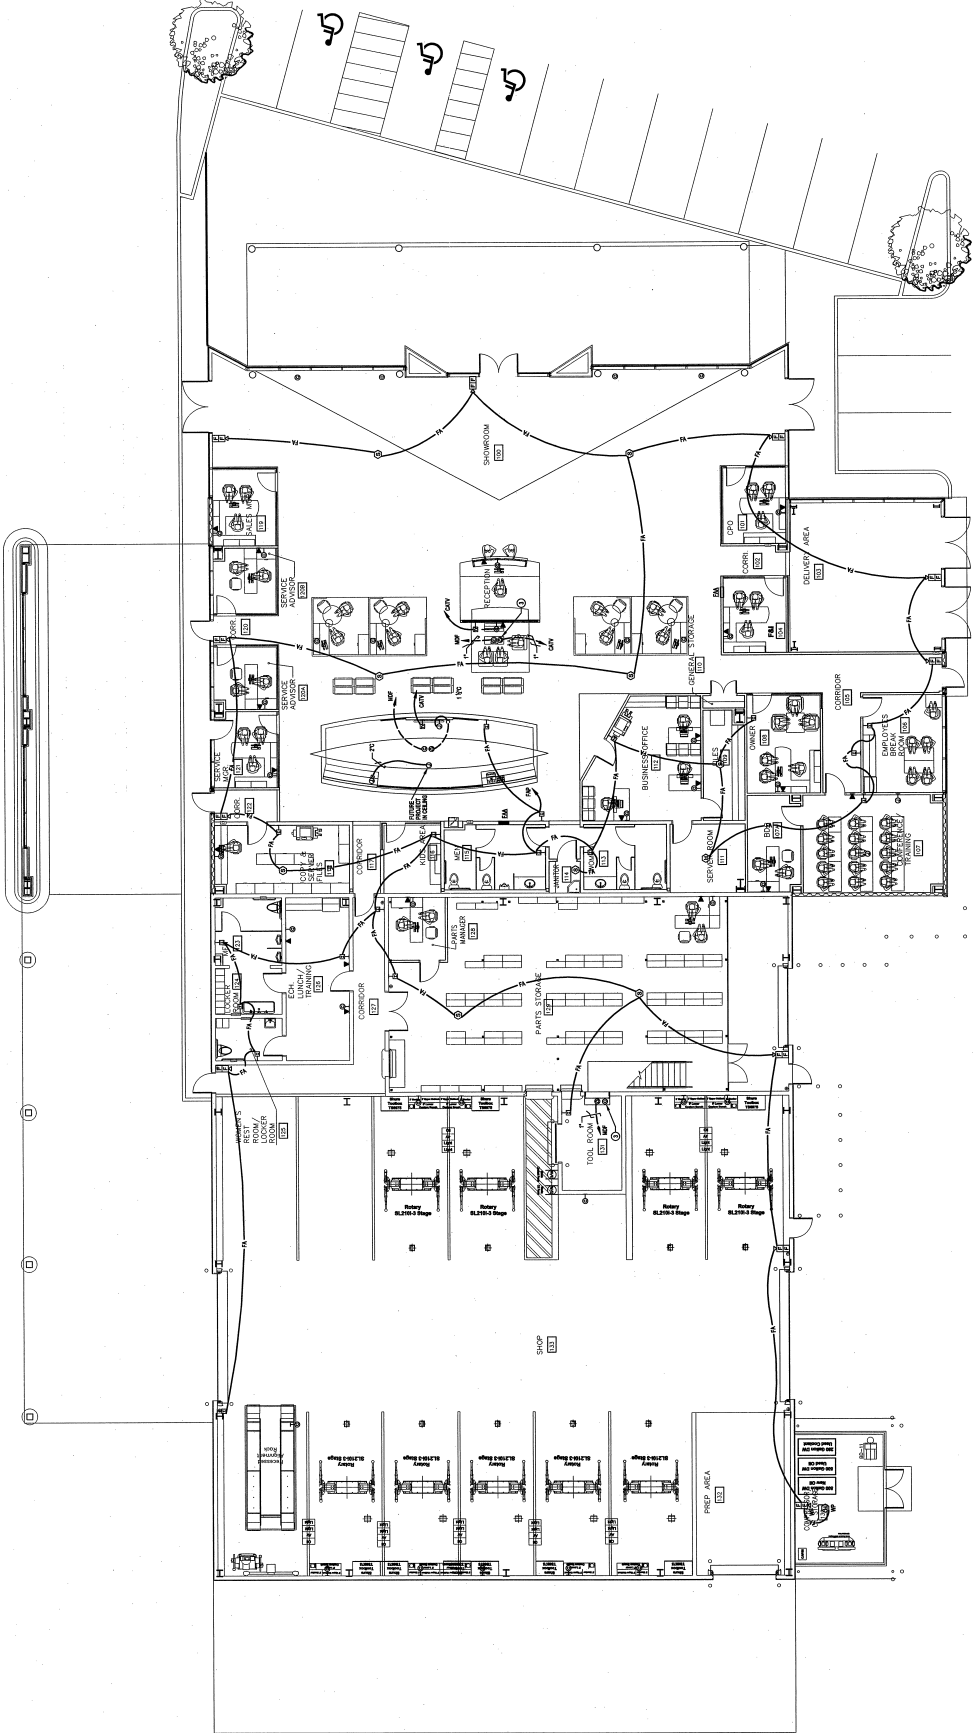

ELECTRICAL LOW VOLTAGE FLOOR PLAN
 SCALE: 1/8"=1'-0"